



Sunbelt Builders, Inc. © DRAWINGS AND SPECIFICATIONS ARE INSTRUMENTS OF SERVICE AND SHALL REMAIN THE PROPERTY OF THIS CORPORATION WHETHER THE PROJECT FOR WHICH THEY ARE MADE IS EXECUTED OR NOT. THEY ARE NOT TO BE USED ON OTHER PROJECTS OR EXTENSIONS TO THIS PROJECT EXCEPT BY AGREEMENT IN WRITING AND APPROPRIATE COMPENSATION TO THIS CORPORATION.

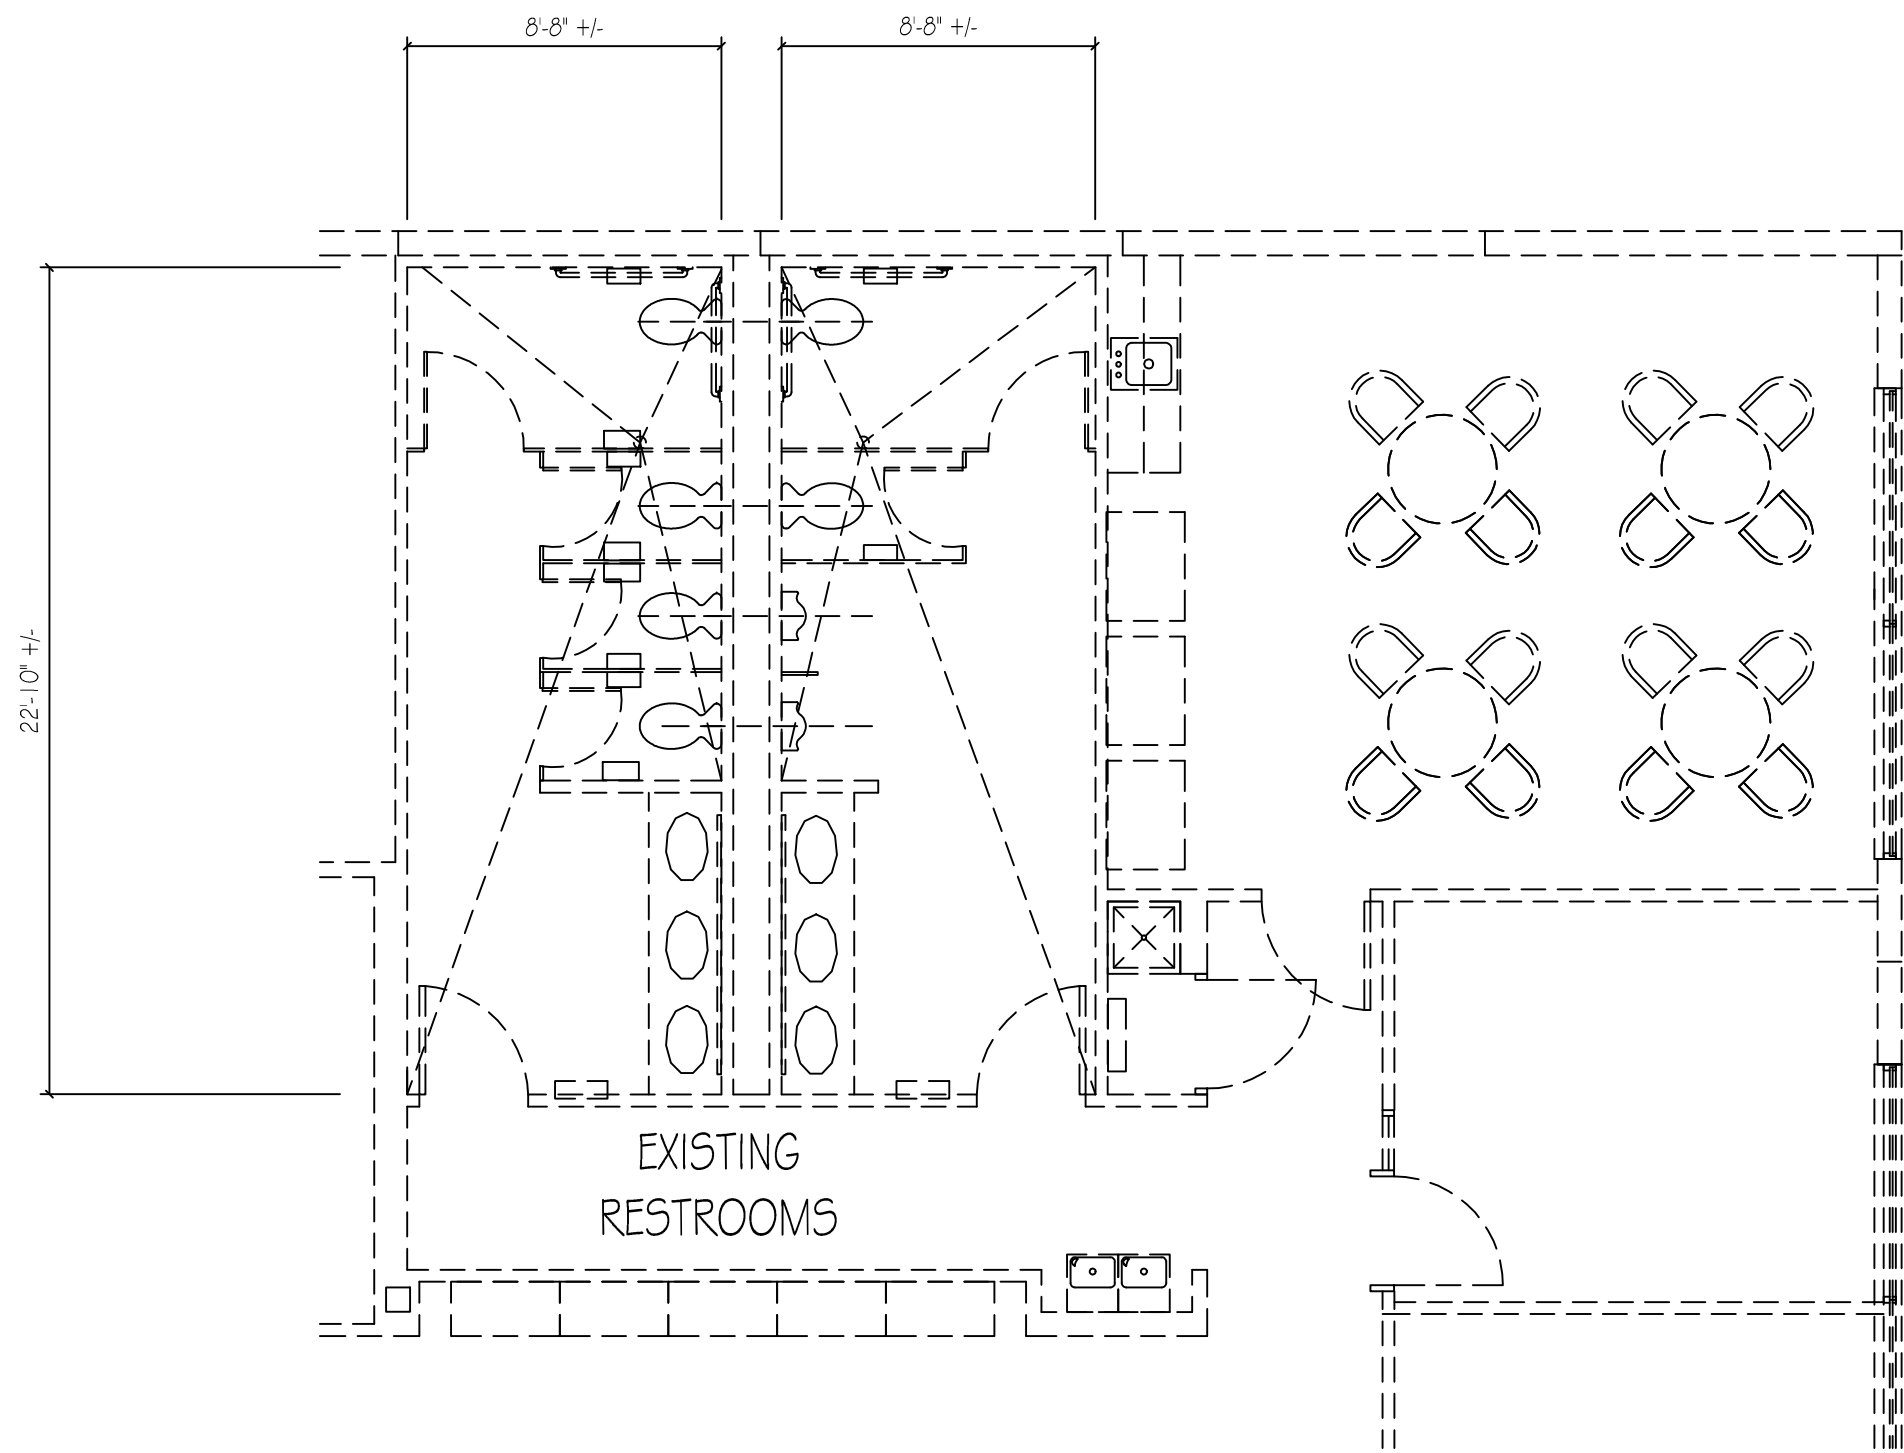

Project '23F' Floor Plan  
SCALE: 3/16" = 1'-0"

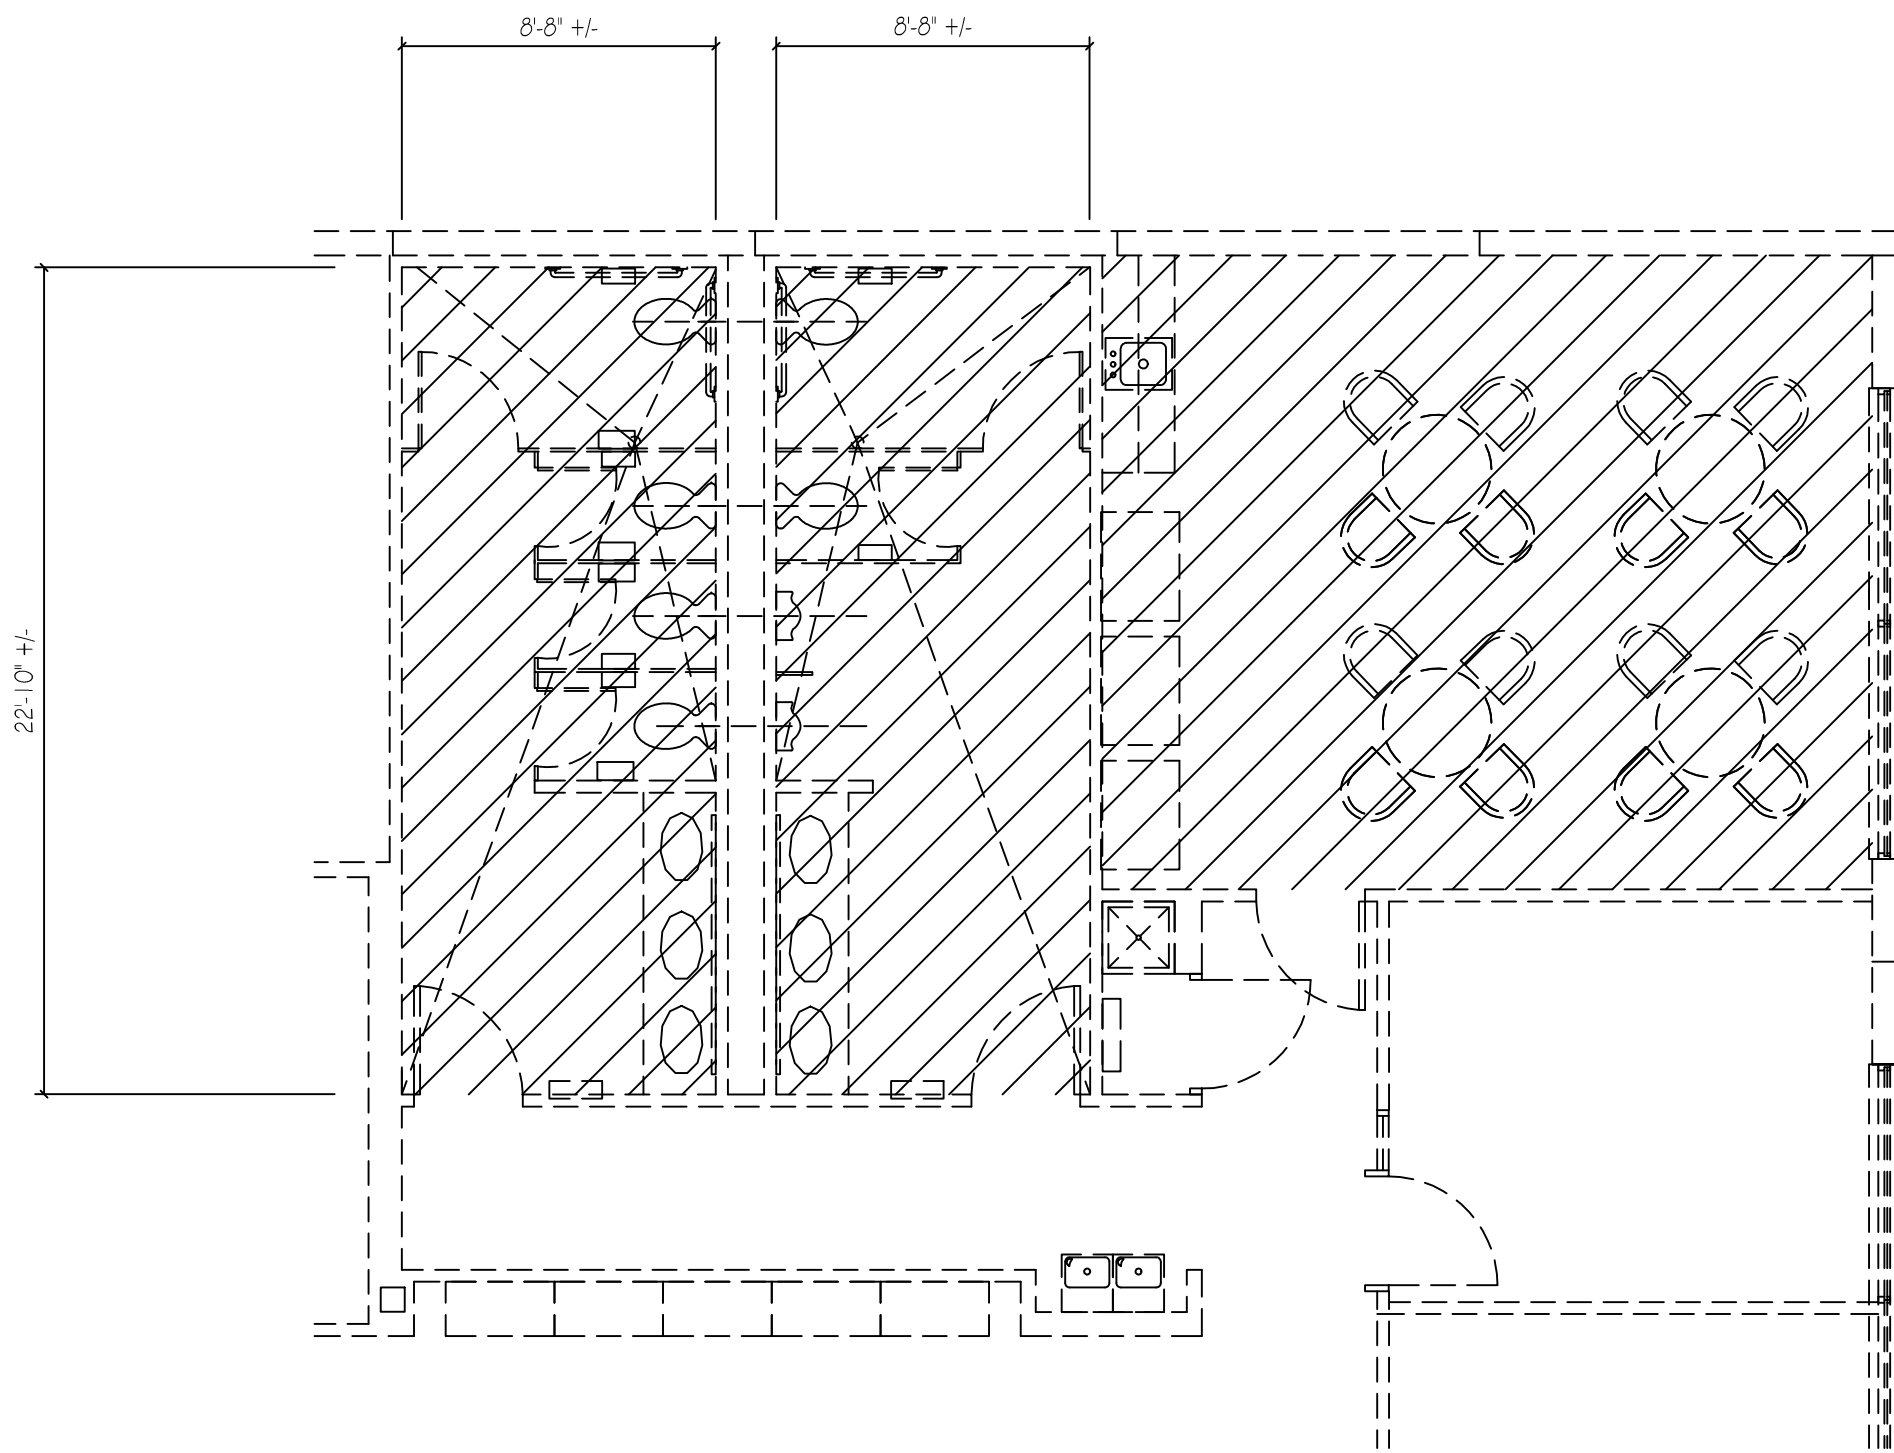

Project '23F' Demo Plan  
SCALE: 3/16" = 1'-0"

PROJECT '23F" - SCOPE OF WORK

1. DEMO ALL WALL AND FLOOR TILE.
2. DEMO EXISTING COUNTERTOP, RESTROOM ACCESSORIES, PARTITIONS AND PLUMBING FIXTURES.
3. FURNISH AND INSTALL NEW SOLID SURFACE COUNTERTOP IN RESTROOMS.
4. FURNISH AND INSTALL NEW FLOOR AND WALL TILE AND BASE. WALL TILE TO 4'-0" A.F.F. (MAPEI PRODUCT) (OWNER TO SELECT COLOR) - RESTROOM AREA
5. FURNISH AND INSTALL NEW TILE FLOOR (MAPEI PRODUCT) (PREPARE EXISTING CONCRETE AS REQUIRED PRIOR TO INSTALL) (OWNER TO SELECT COLOR) - BREAKROOM
6. PAINT EXISTING DOOR FRAMES. (OWNER TO SELECT COLOR)
7. PAINT EXISTING GYPSUM WALLS ABOVE NEW WALL TILE. (OWNER TO SELECT COLOR)
8. FURNISH AND INSTALL NEW RESTROOM PARTITIONS.
9. FURNISH AND INSTALL NEW RESTROOM ACCESSORIES.
10. FURNISH AND INSTALL NEW PLUMBING FIXTURES.

ALPHA BLDG SET 11-06-2025

Sunbelt  
BUILDERS™

10641 HWY 38, COVINGTON, GA 30014 t 770.786.3031 f 770.786.3048

Architect or Engineer Seal

A New Interior Renovation Project For  
Nisshinbo Automotive

14187 Nisshinbo Drive  
Covington, Georgia

1	09-06-2023 Punch Plans
3	07-25-2024 Customer Revisions

Project No.  
• 00-00

Cad File Name  
• 00-00\_NA\_07\_A24F

Drawing Scale  
• 3/16" = 1'-0"

Sheet Title  
• Project 23F  
Floor Plan

Drawn  
• dcm

Checked  
• mbm

Sunbelt Builders, Inc. ©  
DRAWINGS AND SPECIFICATIONS ARE INSTRUMENTS OF SERVICE AND SHALL REMAIN THE PROPERTY OF THIS CORPORATION WHETHER THE PROJECT FOR WHICH THEY ARE MADE IS EXECUTED OR NOT. THEY ARE NOT TO BE USED ON OTHER PROJECTS OR EXTENSIONS TO THIS PROJECT EXCEPT BY AGREEMENT IN WRITING AND APPROPRIATE COMPENSATION TO THIS CORPORATION.

DRAWING NUMBER

A-2.3F

7 of \*